


NOTES

- THIS DRAWING SHALL BE READ IN CONJUNCTION WITH THE CPW RIBA STAGE 4 SPECIFICATION AND RELEVANT ARCHITECTS AND ENGINEERS DRAWINGS.
- THIS DRAWING IS FOR RIBA STAGE 4 PURPOSES TO INDICATE DESIGN INTENT ONLY. FURTHER DESIGN DEVELOPMENT IS REQUIRED.
- THE ELECTRICAL CONTRACTOR SHALL CO-ORDINATE ALL ELECTRICAL SERVICES WITH MECHANICAL SERVICES & STRUCTURE.
- FINAL SETTING OUT IF EQUIPMENT SHALL BE TO THE ARCHITECTS ROOM LAYOUTS AND REFLECTIVE CEILING PLANS. CONTRACTOR TO ENSURE COORDINATION. ALL ITEMS OF EQUIPMENT MUST BE LOCATED TO FACILITATE SUITABLE ACCESS AND MAINTENANCE. CONDUCTORS OR PROPRIETARY LINKS.
- THE ELECTRICAL INSTALLATION MUST COMPLY IN FULL WITH THE REQUIREMENTS OF BS 7671 18TH (2ND AMMENDMENT) EDITION WIRING REGULATIONS. EXISTING SERVICES TO BE RECONNECTED TO NEW DISTRIBUTION BOARDS AND MADE COMPLIANT WITH BS 7671 18TH (2ND AMMENDMENT) EDITION WIRING REGULATIONS.
- FOR EXACT LOCATION OF THE MECHANICAL EQUIPMENT PLEASE REFER TO THE MECHANICAL LAYOUTS.

LEGEND:

- TP&N MCB DISTRIBUTION BOARD
- SWITCHED SINGLE SOCKET OUTLET (LABELLED FOR CLEANING PURPOSES)
- SINGLE SWITCHED SOCKET OUTLET
- DOUBLE SWITCHED SOCKET OUTLET
- SWITCHED FUSED CONNECTION UNIT
- EMERGENCY SHUT OFF SWITCH
- SINGLE RJ45 CAT 6A OUTLET
- DOUBLE RJ45 CAT 6A OUTLET
- THREE PHASE ISOLATOR
- DADO TRUNKING
- CONTACTOR
- POWER POLE

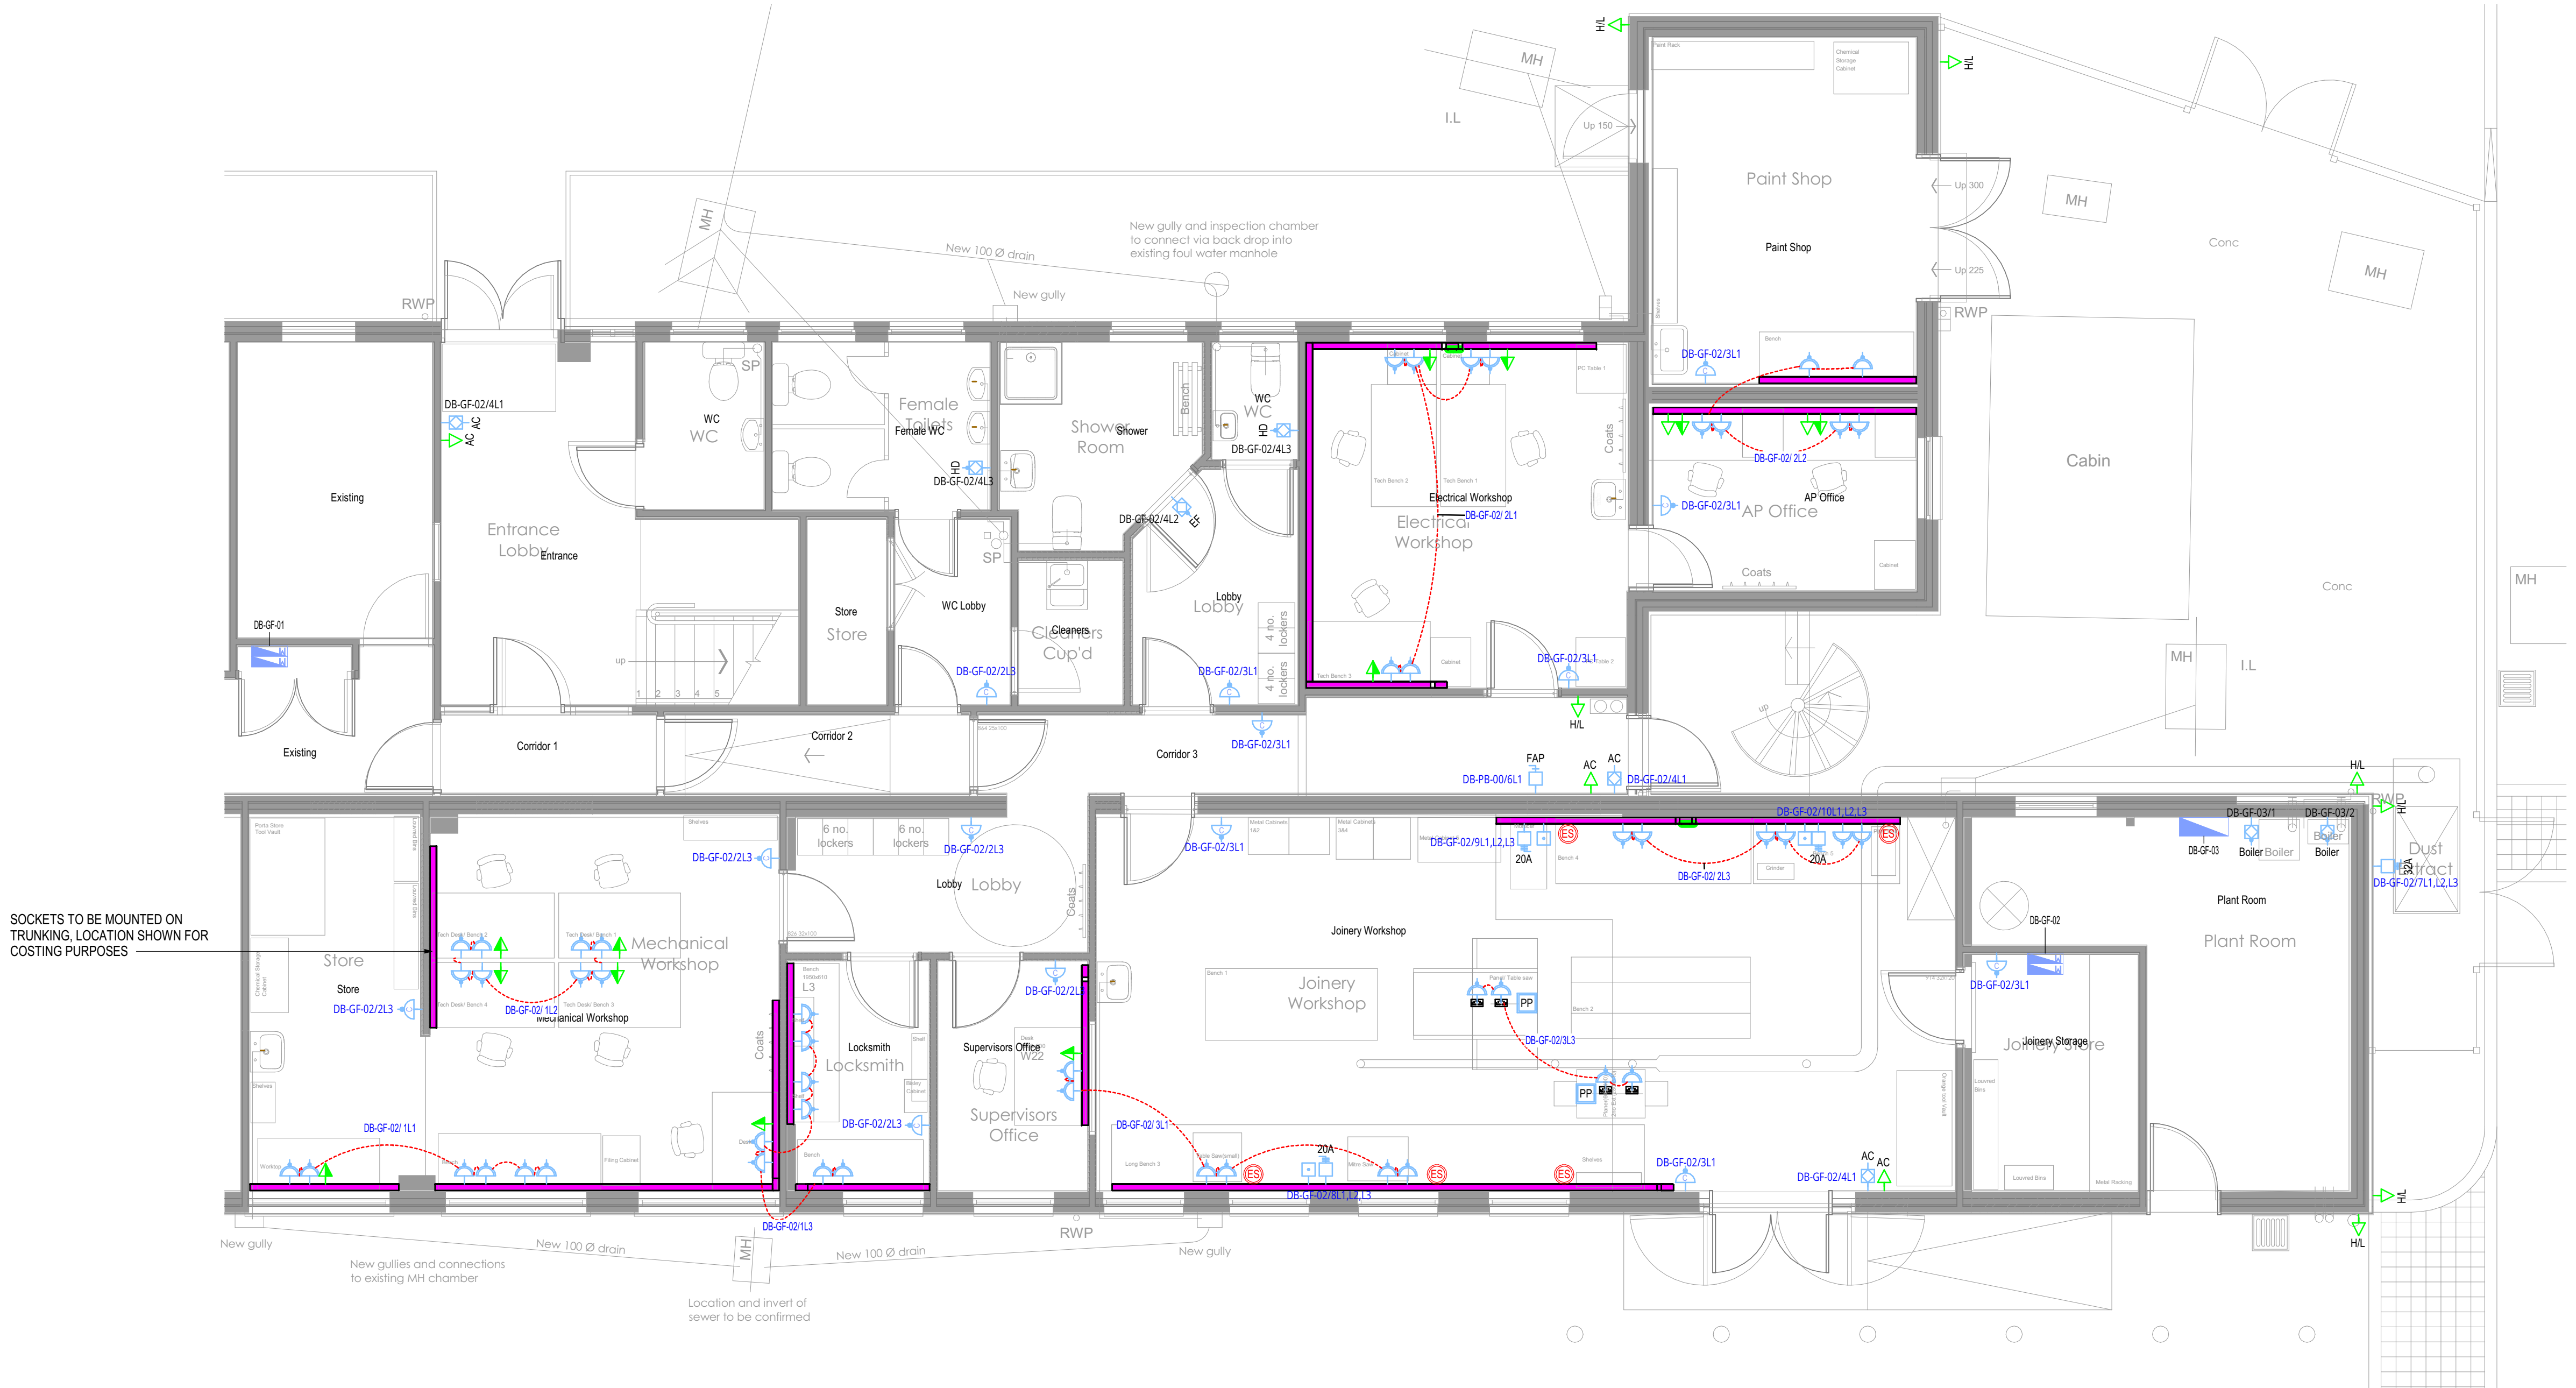

1 Proposed Small and Data Layout  
1:50

THIS DRAWING IS AN INDICATIVE LAYOUT ONLY, DEMONSTRATING THE CONCEPTUAL REQUIREMENTS CORRELATING WITH THE AGREED SOLUTIONS. THE PURPOSE OF THIS DRAWING IS TO DEMONSTRATE DESIGN INTENT, FOR FURTHER DEVELOPMENT BY THE RELEVANT SERVICES DESIGNER ONLY.

T01  
REV

04/06/2023  
DATE

STAGE 4 TENDER ISSUE  
DESCRIPTION

WS  
SP  
VE

CPW

www.cpw-p.com

Address  
Third Floor, Bolsover House  
5-6 Clipstone Street, London  
W1W 6BB

Phone  
+ 44 (0) 203 870 4790

Email  
london@cpw-p.com

RIBA STAGE

STAGE 4

STATUS

TENDER

CLIENT

NHS TRUST

PROJECT

CTC WORKSHOP RELOCATION

DRAWING TITLE

ELECTRICAL SERVICES

SMALL POWER AND DATA PHILOSOPHY LAYOUT

GROUND FLOOR

SCALE (A1)

1:50

DATE

JUNE 2023

BY

WS

VE

KW

Proj ID	Originator	Volume	Level	Type	Role	Number	Suitability	Revision
230114	CPW	ZZ	00	DR	E	210001	S4	T01

230114-CPW-ZZ-00-DR-E-210001 S4 T01  
CPW Project No. 230114

LINKED FILES

d230518 Proposed Layout