


FIRE PRECAUTION LEGEND

- NOTIONAL DIRECTION OF ESCAPE
- LINE OF 30 MINUTE STRUCTURAL FIRE SEPARATION
- LINE OF 60 MINUTE STRUCTURAL FIRE SEPARATION
- SMOKE DETECTOR
- HEAT DETECTOR
- ILLUMINATED FIRE EXIT SIGN OVER DOOR
- FIRE EXIT SIGN WITH DIRECTIONAL ARROW

NOTE
FIRE CONSULTANT TO ADVISE ON FIRE EXTINGUISHER
REQUIREMENTS AND POSITIONING.

PLEASE REFER TO DRAWING 5087.333 FOR FIRE
PENETRATION PROTECTION DETAILS

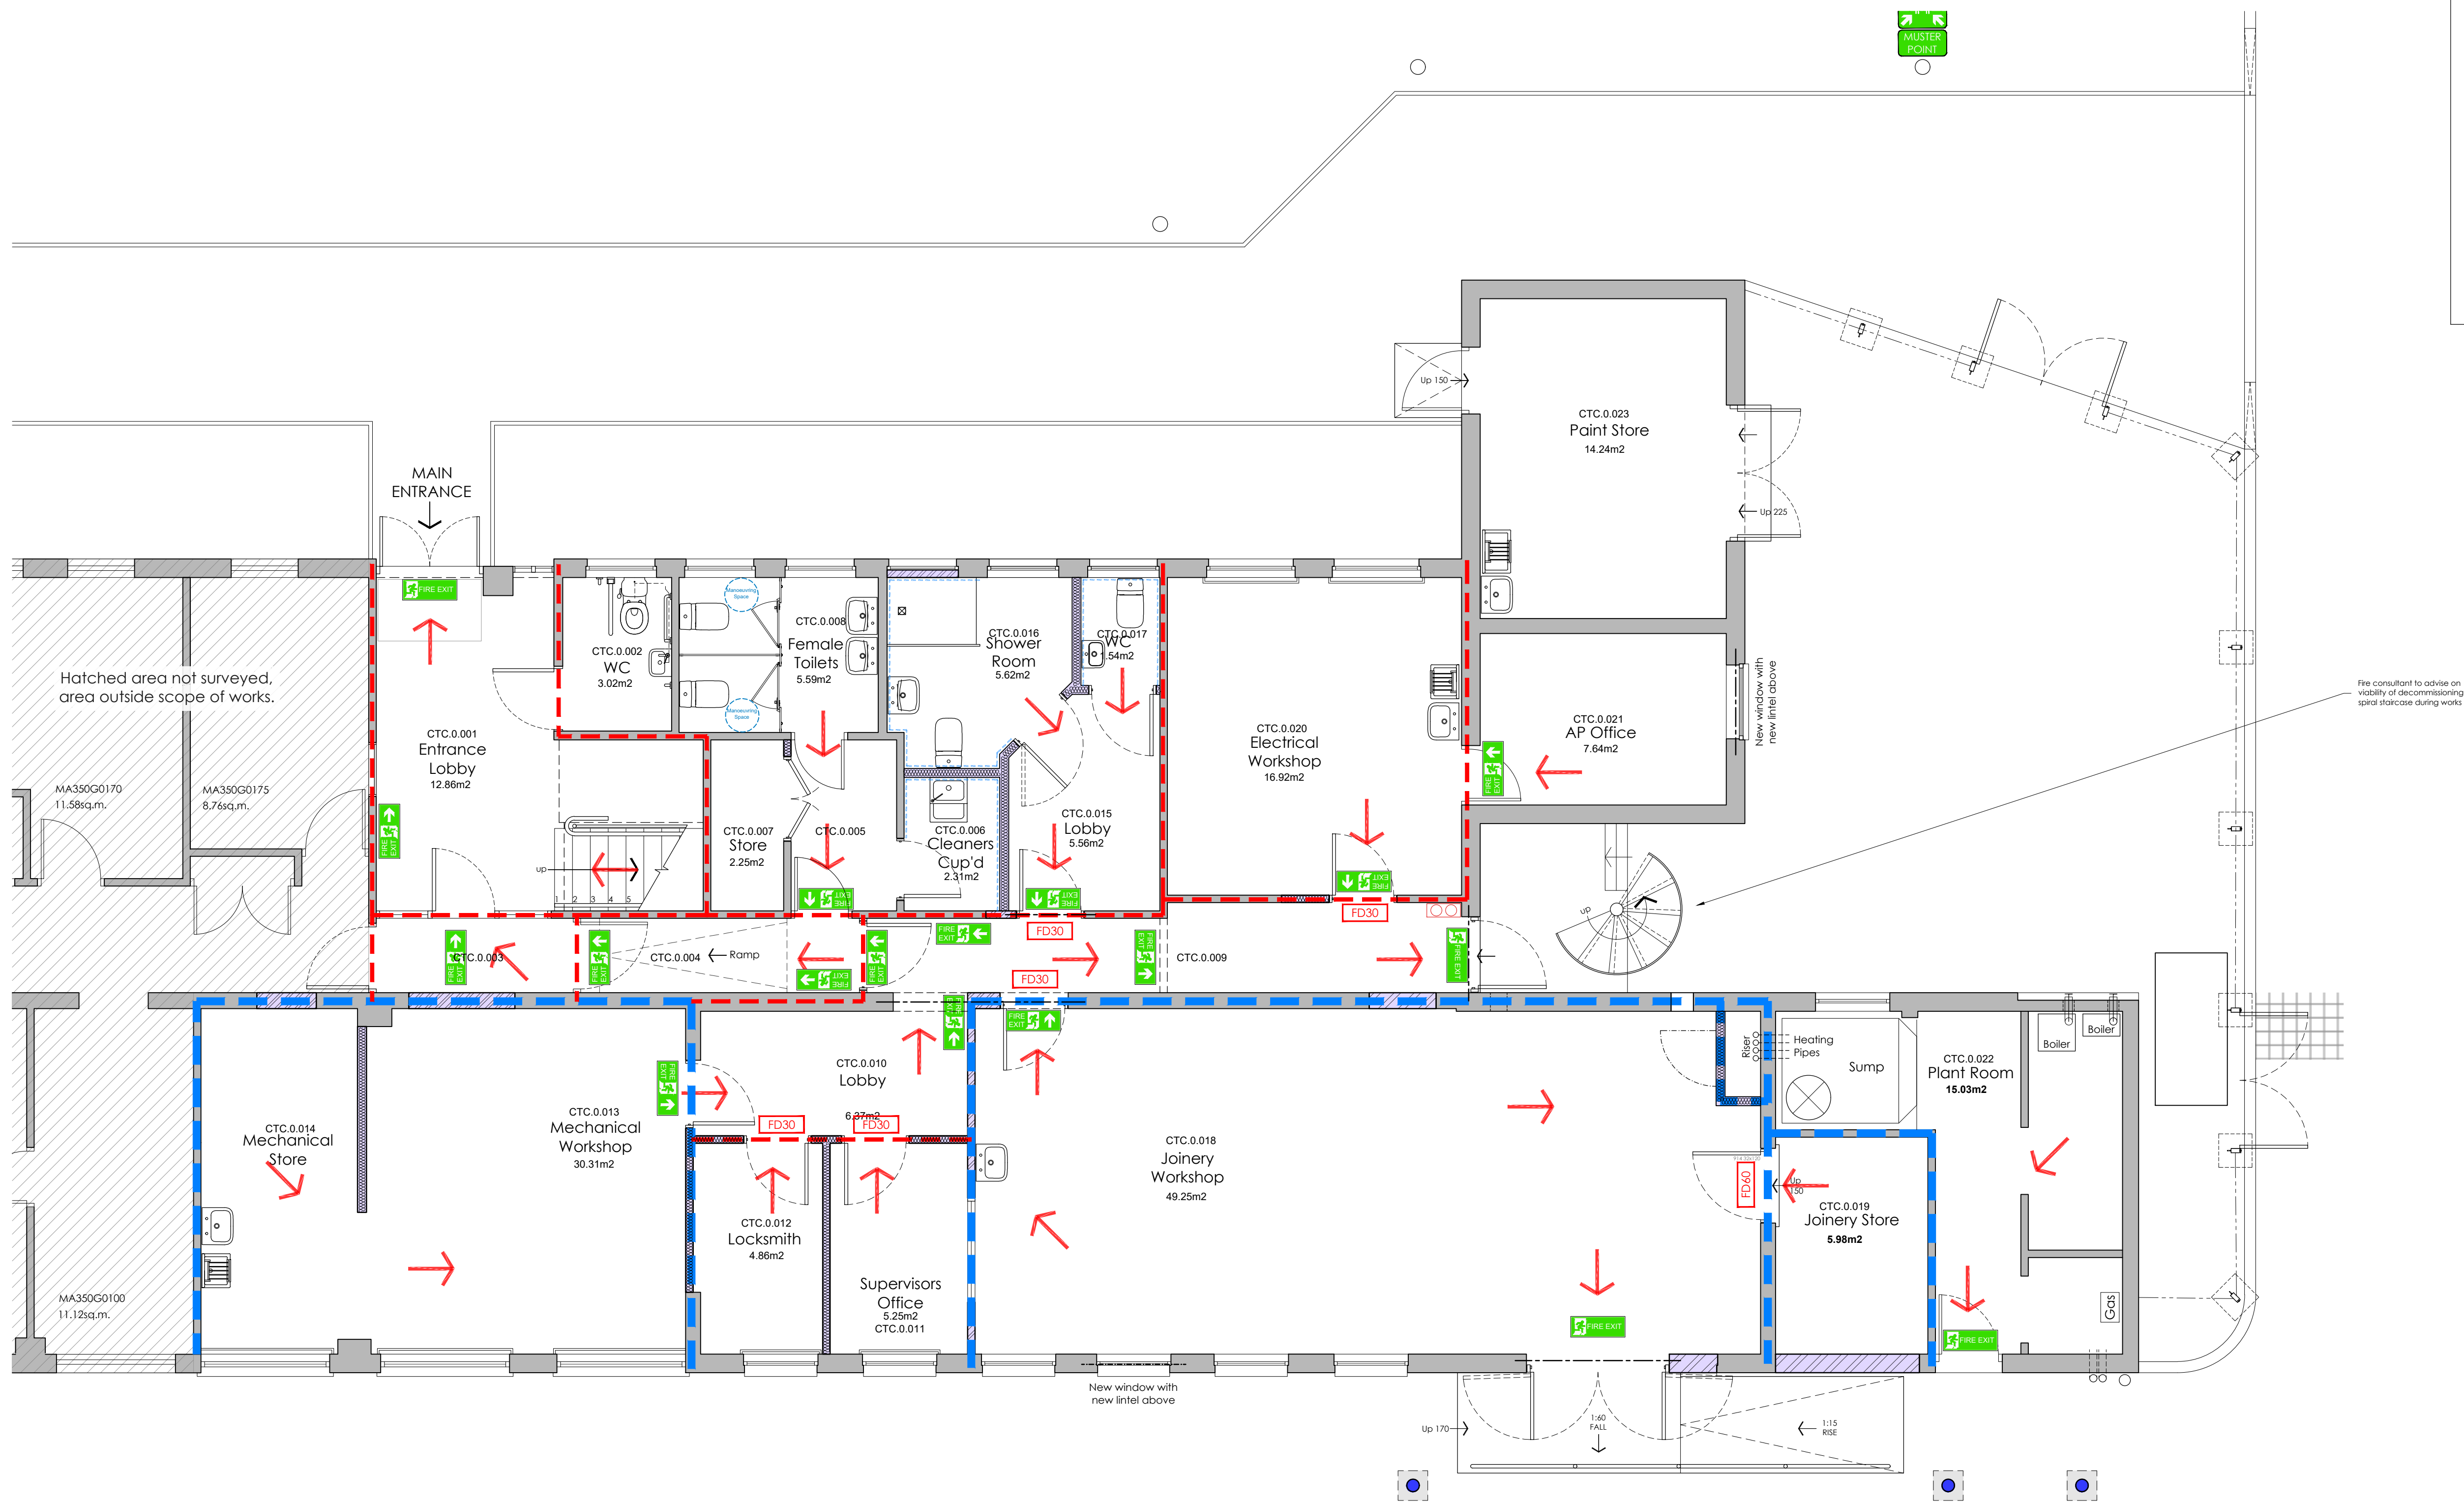

TENDER ISSUE

T2	04.08.23	AMENDED FOLLOWING CLIENT FEEDBACK	JOH	DG
T1	13.07.23	TENDER ISSUE	JOH	TAJC
P3	04.07.23	FIRST FLOOR ADDED	JOH	DG
P2	18.05.23	DESIGN FROZEN	JOH	DG
P1	16.05.23	INITIAL PRELIMINARY DRAWINGS	JOH	TAJC
REV	DATE	DESCRIPTION	BY	APPD

CLIENT
South London and Maudsley NHS Foundation Trust

PROJECT
**Clinical Treatment Centre
Maudsley Hospital
Denmark Hill
London. SE5 8AZ**

DRAWING TITLE
**Proposed Fire Strategy Plan
Ground Floor**

DATE	March 2023	DWG. No.	5087.140	REV.	T2
SCALE	1:50 (A1)				
DRAWN BY:	DG	DATED	27.03.2023		
CHECKED BY:	TC	DATED	17.07.2023		

AK DESIGN PARTNERSHIP LLP
CHARTERED BUILDING CONSULTANCY
BUILDING SURVEYORS
BUILDING DESIGNERS
PROJECT MANAGERS

AKDP
CEME INNOVATION CENTRE
CEME CAMPUS
MARSH WAY
RAINHAM
RM13 9EU

TEL: 020 8596 7070
E-MAIL: office@akdesign.co.uk
WEB SITE: www.akdesign.co.uk

Proposed Ground Floor Plan Scale 1:50

